
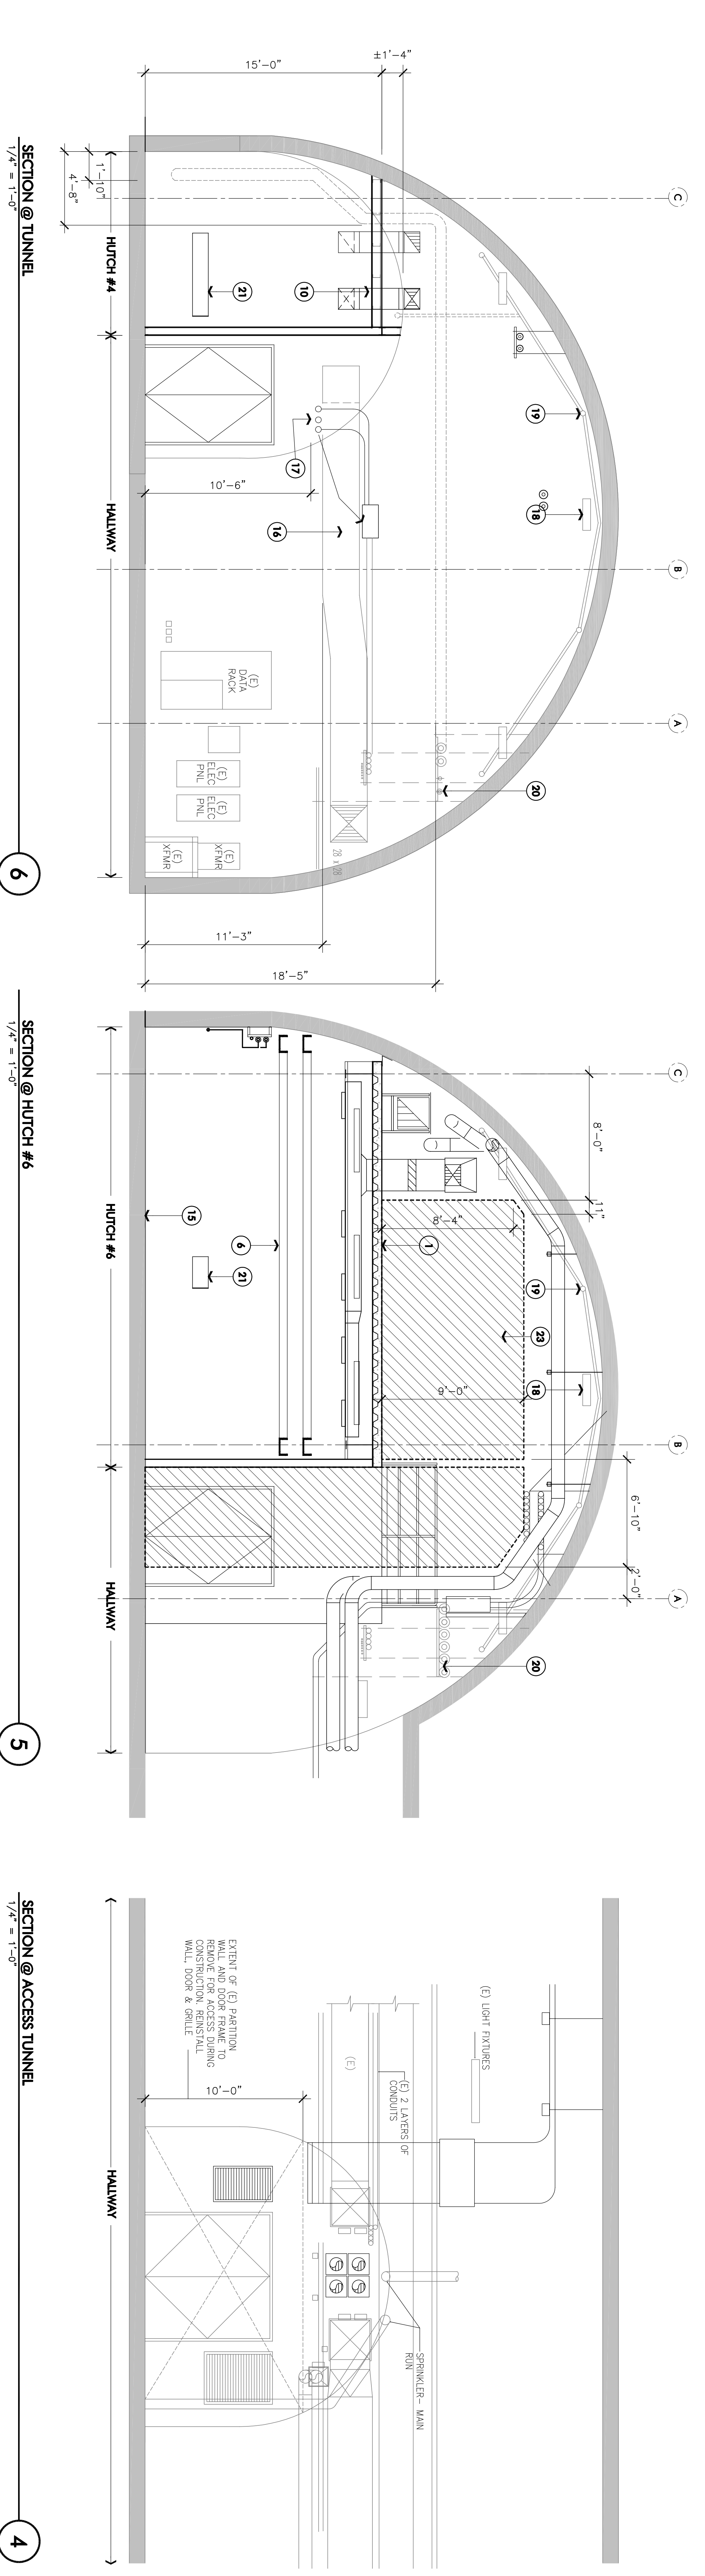


REV	DESCRIPTION	DRN	CHK	APP	DATE
1	TITLE 1				11/04/08
2	TITLE-II 80% DESIGN REVIEW				12/23/08
3	TITLE-II 90% DESIGN REVIEW				02/25/09
4	TITLE-II ARCH REFERENCE SET				03/12/09

CHECK SET 03/17/09

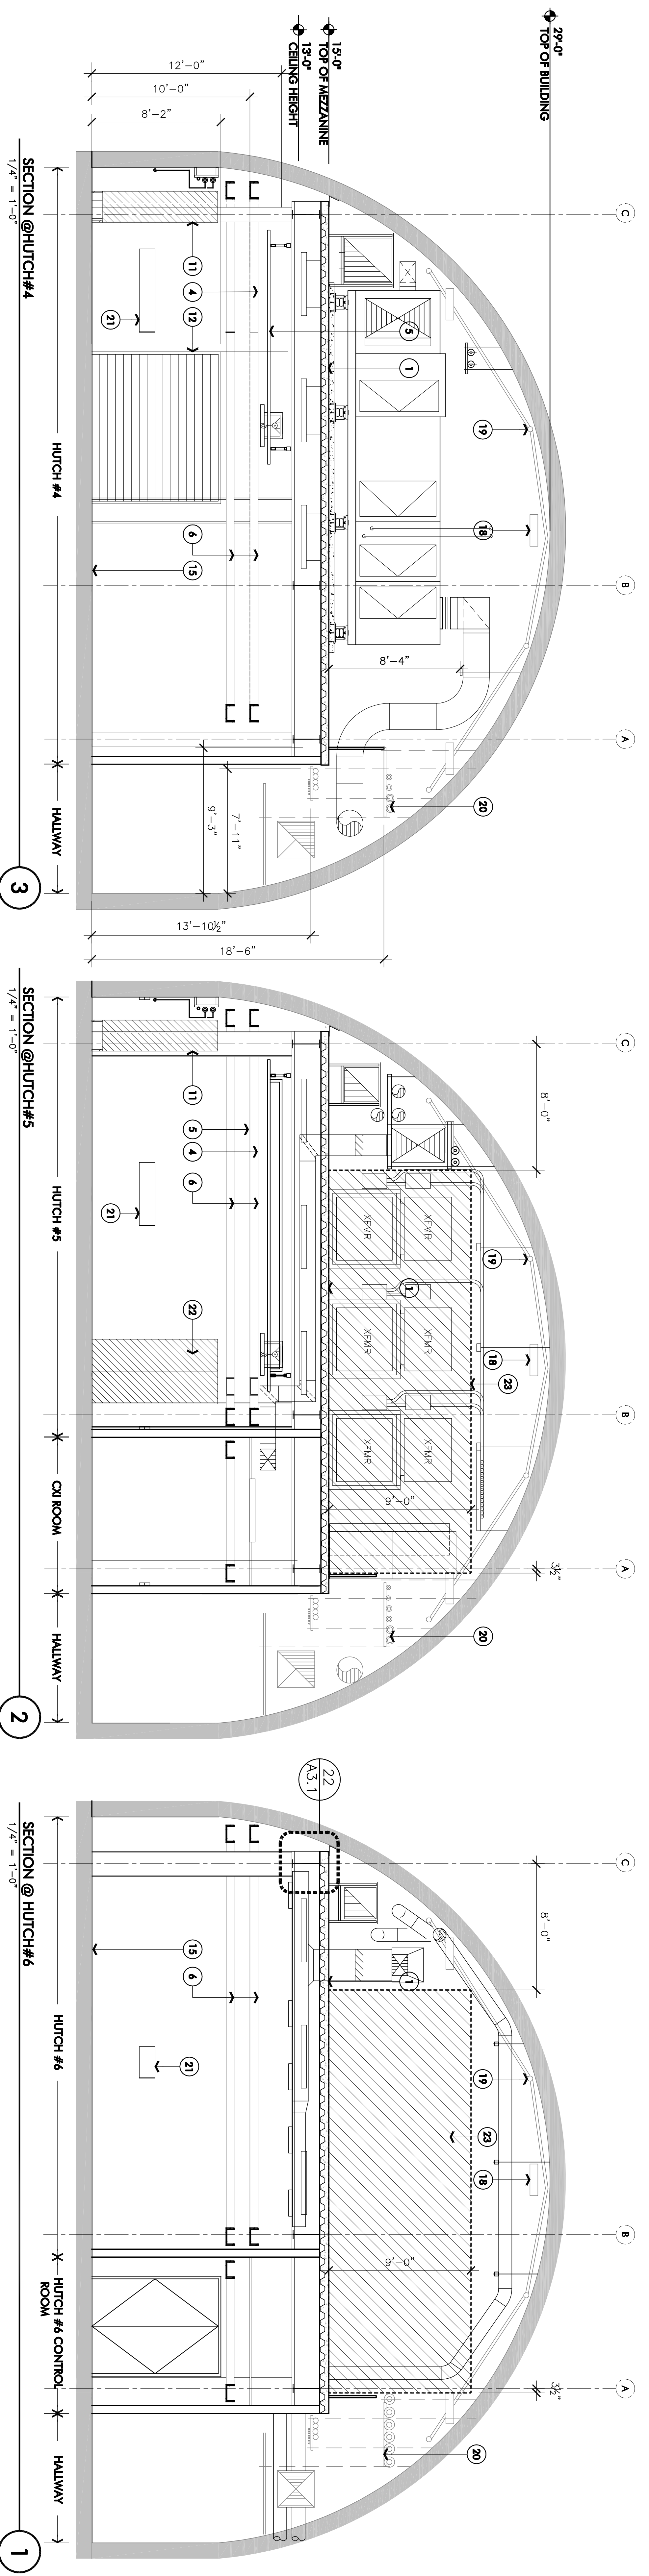

- KEYNOTES**
- MEZZANINE PLATFORM, CONC. OVER METAL DECK. SEE STRUCTURAL DRAWINGS.
 - MECHANICAL PLATFORM, SEE STRUCTURAL DRAWINGS.
 - SEISMIC SEPARATION, SEE STRUCTURAL FOR CLEAR DISTANCE & COVER.
 - BRIDGE CRANE TRACKS TO BE HUNG FROM STRUCTURAL STEEL.
 - BRIDGE CRANE HOST.
 - CABLE TRAYS, SEE ELECTRICAL FOR CABLE TRAY SPECIFICATIONS.
 - NEW GUARD RAILS, PAINT TO MATCH EXISTING GUARD RAILS AT RAW PLATFORM, SEE DETAIL 20/AS.2.
 - REMOVABLE GUARDRAILS, SEE DETAILS 20/AS.2.
 - NEW BRIDGE W/ GUARD RAIL AND METAL GRATING FLOOR.
 - LEAD LINED GYP. BD, CEILING, SEE REFERENCED DETAILS.
 - FUTURE SERVER RACKS BY OWNER. (N.I.C. SHOWN FOR REFERENCE ONLY)
 - ROLL-UP DOOR, SEE DOOR SCHEDULE SHEET A3.2.
 - SLIDING DOOR BY OWNER, SEE DOOR SCHEDULE SHEET A3.2.
 - METAL STAIRS TO MEZZANINE, DESIGN-BUILD PER REFERENCED DETAILS.
 - EXISTING CAVERN CONC. FLOOR, WALL OR CEILING.
 - EXISTING DUCTS.
 - RELOCATE EXISTING PULL BOX, SEE ELECTRICAL FOR DETAILS.
 - EXISTING LIGHT FIXTURES TO REMAIN.
 - EXISTING SPRINKLER SYSTEM TO REMAIN.
 - WALL OPENING FOR BEAM PIPE, COORDINATE FINAL SIZE AND LOCATION IN FIELD WITH USERS.
 - GAS CABINET, N.I.C.
 - STAY CLEAR ZONE.

DGA planning architecture | interiors
 550 Ellis Street
 Mountain View, CA 94040
 Tel: 650.943.1660
 Fax: 650.943.1670

SCALE: 1/8"=1'-0"
 DO NOT SCALE DRAWING

SIAC NATIONAL ACCREDITED LABORATORY
 U.S. DEPARTMENT OF ENERGY
 ARCHITECTURAL SECTIONS

ARCHITECT: **LCLS FEH ARCHITECTURAL SECTIONS**

ID: 383-901-14-CO

AA.2